


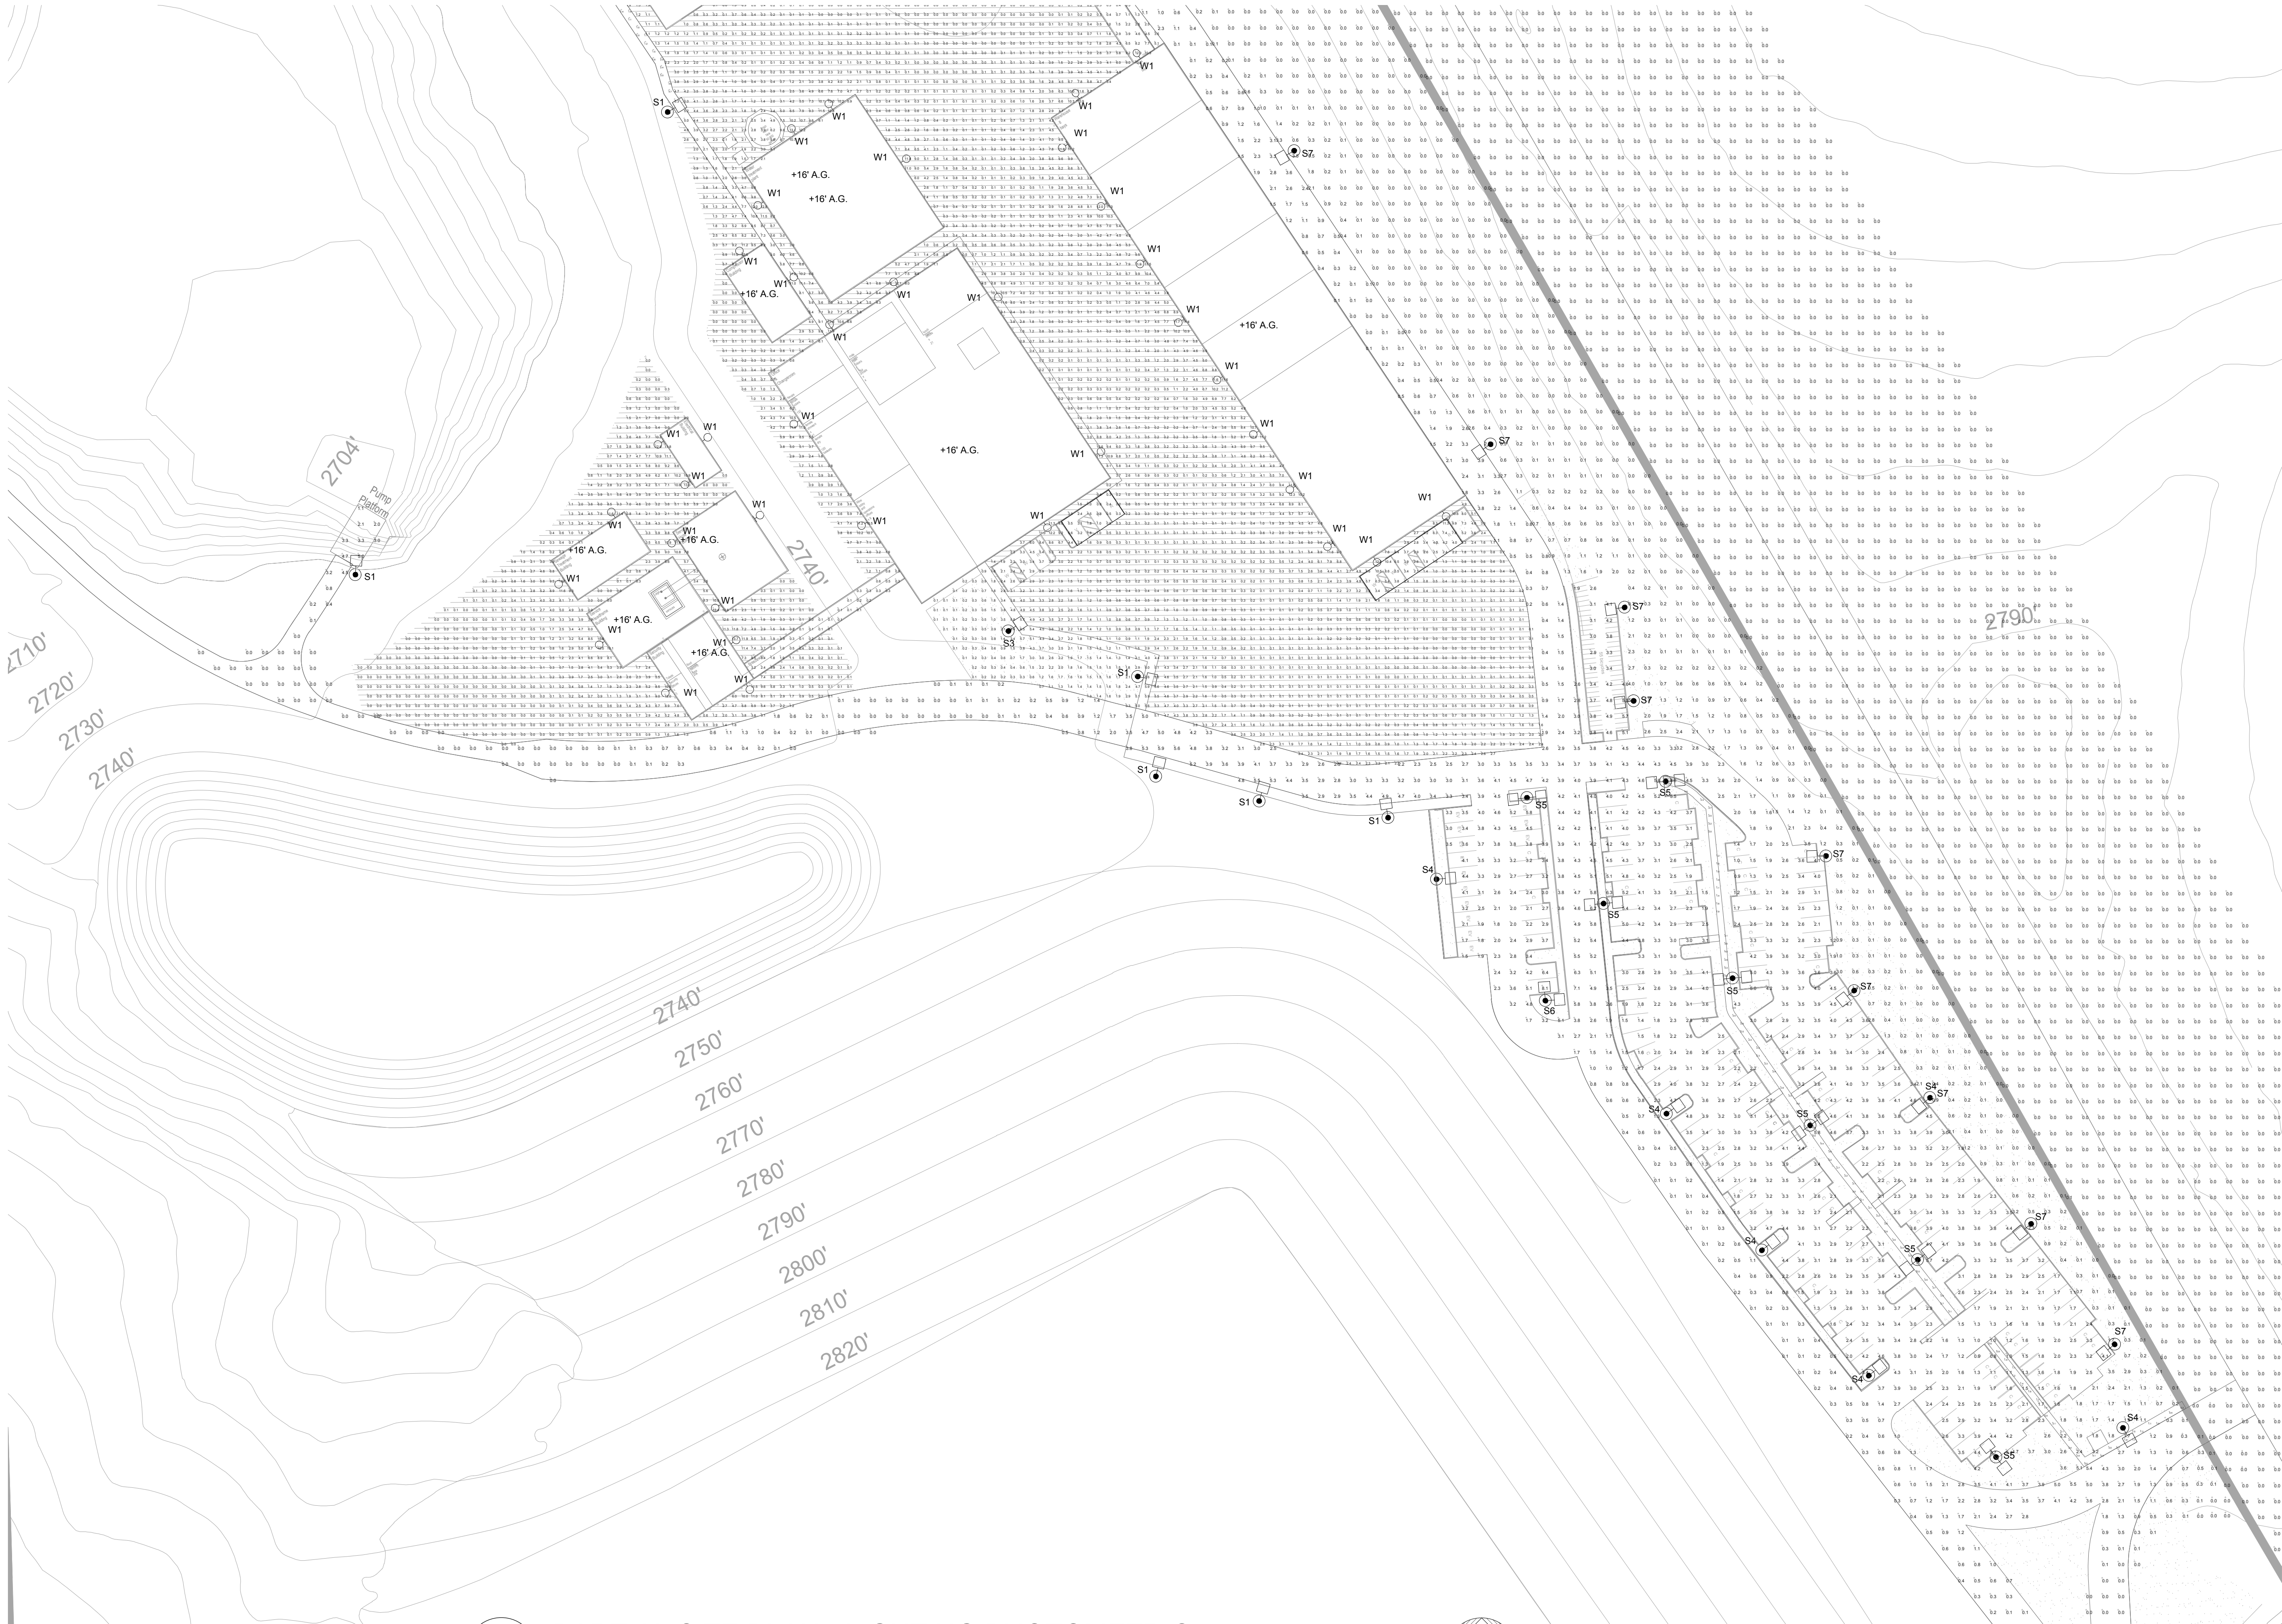

1 PARTIAL SITE PLAN - LIGHTING PHOTOMETRIC
E100 SCALE: 1" = 50'-0"

NO.	REVISIONS	DATE	BY
1		X/XX/XX	

M. NELIS
ENGINEERING, INC.
Electrical Engineers | Lighting Designers
100 Howe Ave., Suite 205N
Sacramento, CA 95825-8217
www.mnelisengineering.com
Tel: (916) 923-4400 Fax: (916) 923-4410
PROJECT #: 19301.21

REGISTERED PROFESSIONAL ENGINEER
Jesse U. Bastian
No. E20229
Exp. 03-31-21
ELECTRICAL
STATE OF CALIFORNIA
01-17-20

SHEET TITLE:
PARTIAL SITE PLAN -
LIGHTING
PHOTOMETRIC

PROJECT:
Idaho-Maryland Gold Project
Rise Grass Valley Inc.
PO Box 271
Grass Valley, California, USA 95945

Date: 11-11-19
Checked: JUB
Drawn: SG
Scale: AS NOTED
Sheet
E100
Of Sheets